

PARTS LIST




ITEM NO	COMPONENT	PART NO.	DESCRIPTION	MANUFACTURER	QTY	REMARKS
1	FOUNTAIN	-	60" H FLOURISH FOUNTAIN - GFRC	TREVI	1	COLOR OPTIONAL
2		-	8" H X 18" SQUARE BUILT IN RISER - GFRC	TREVI	1	COLOR OPTIONAL
3		-	42" SQUARE X 8-1/2" H PEDESTAL BASE - GFRC	TREVI	1	COLOR OPTIONAL
4		-	39-1/4" X 6" H SQUARE PLASTIC BASIN	TREVI	1	-
5	TUBING	-	3/4" DIA COUPLER END	-	1	PRE-INSTALLED
6		-	3/4" X 1/2" REDUCER	-	1	PRE-INSTALLED
7		-	1/2" DIA x 41" LG PVC PIPE PLAIN END	-	1	PRE-INSTALLED
8	PARTS BAG	C105	5/8" DIA. x 12" LG TUBING - CLEAR VINYL PLAIN END	-	1	-
9		C105	1/2" DIA BALL VALVE	-	1	-
10		C105	PLASTIC SHIMS	EZ - SHIM	6	-
11		C105	1-1/4" RUBBER PLUG	TREVI	1	-
12	PUMP	-	MODEL 1200 - WP3500, 1100 GPH	JEBAO	1	-

NOTE:


Electrical supply must conform with local & national regulation/codes. If in doubt consult an electrician.

To ease connections hot water may be used to soften PVC tubing. Pump and plumbing details may vary.

Precautions should be taken to prevent damage from water freezing in reservoir.

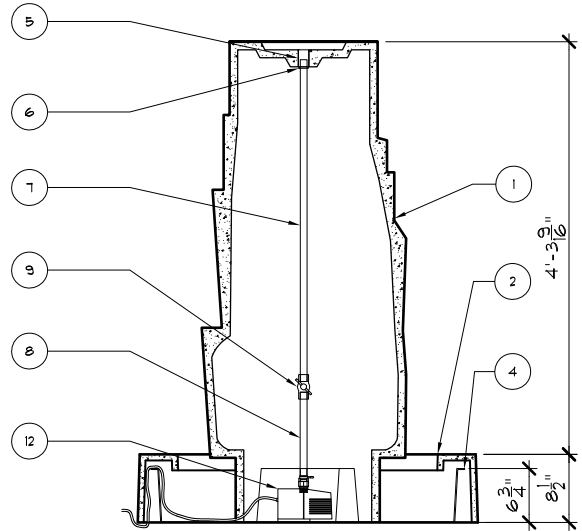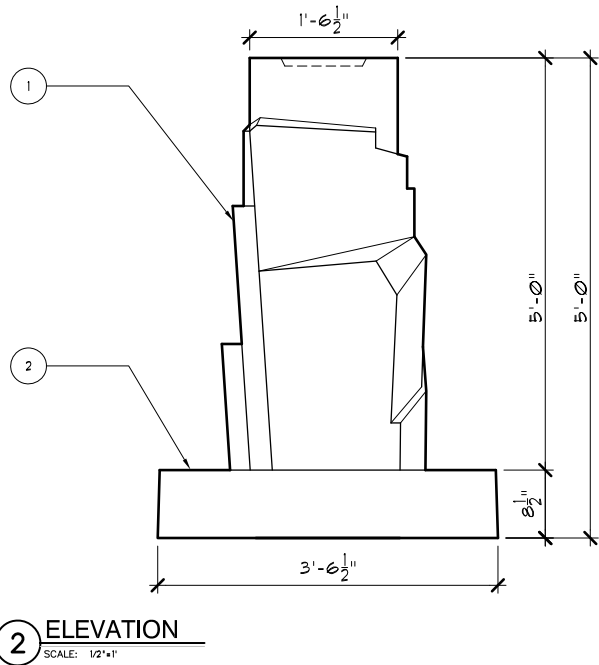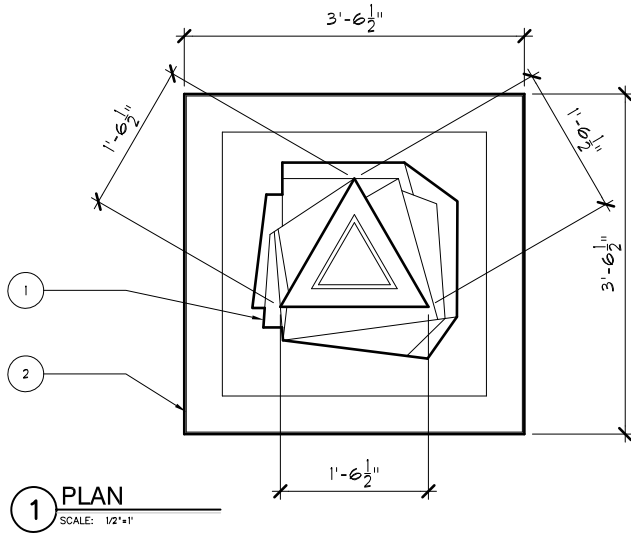

**3 SECTION**  
SCALE: 1/2"=1'

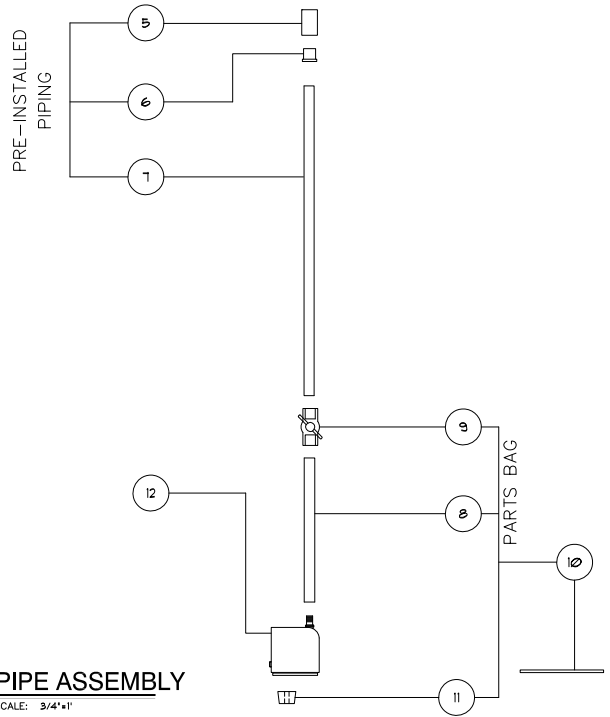

COPYRIGHT 2003 TREVI MANUFACTURING ALL RIGHTS RESERVED

EMANT SHOP.DWG

Yard Art

925.487.7166

www.uniquegardendecor.com

CONTENT FLRSH FLOURISH FOUNTAIN	DRAWING NO FLRSH SHOP
PROJECT FLRSH	SHEET. NO. 1 OF 1